




Plotted By: Dumbauld, Jimmy, Sheet Set: 2nd, Layout: L4.00, December 19, 2024, 02:11:51pm, K:\ORL\LA\249659000 Lake Mary Office Bldgs LA\CAD\CONS\PlanSheets\L4.00 PHOTOMETRICS PLAN.dwg
This document, together with the concepts and designs presented herein, is intended only for the specific purpose and client for which it was prepared. Reuse of and improper reliance on this document without written authorization and adaptation by Kimley-Horn and Associates, Inc. shall be without liability to Kimley-Horn and Associates, Inc.

 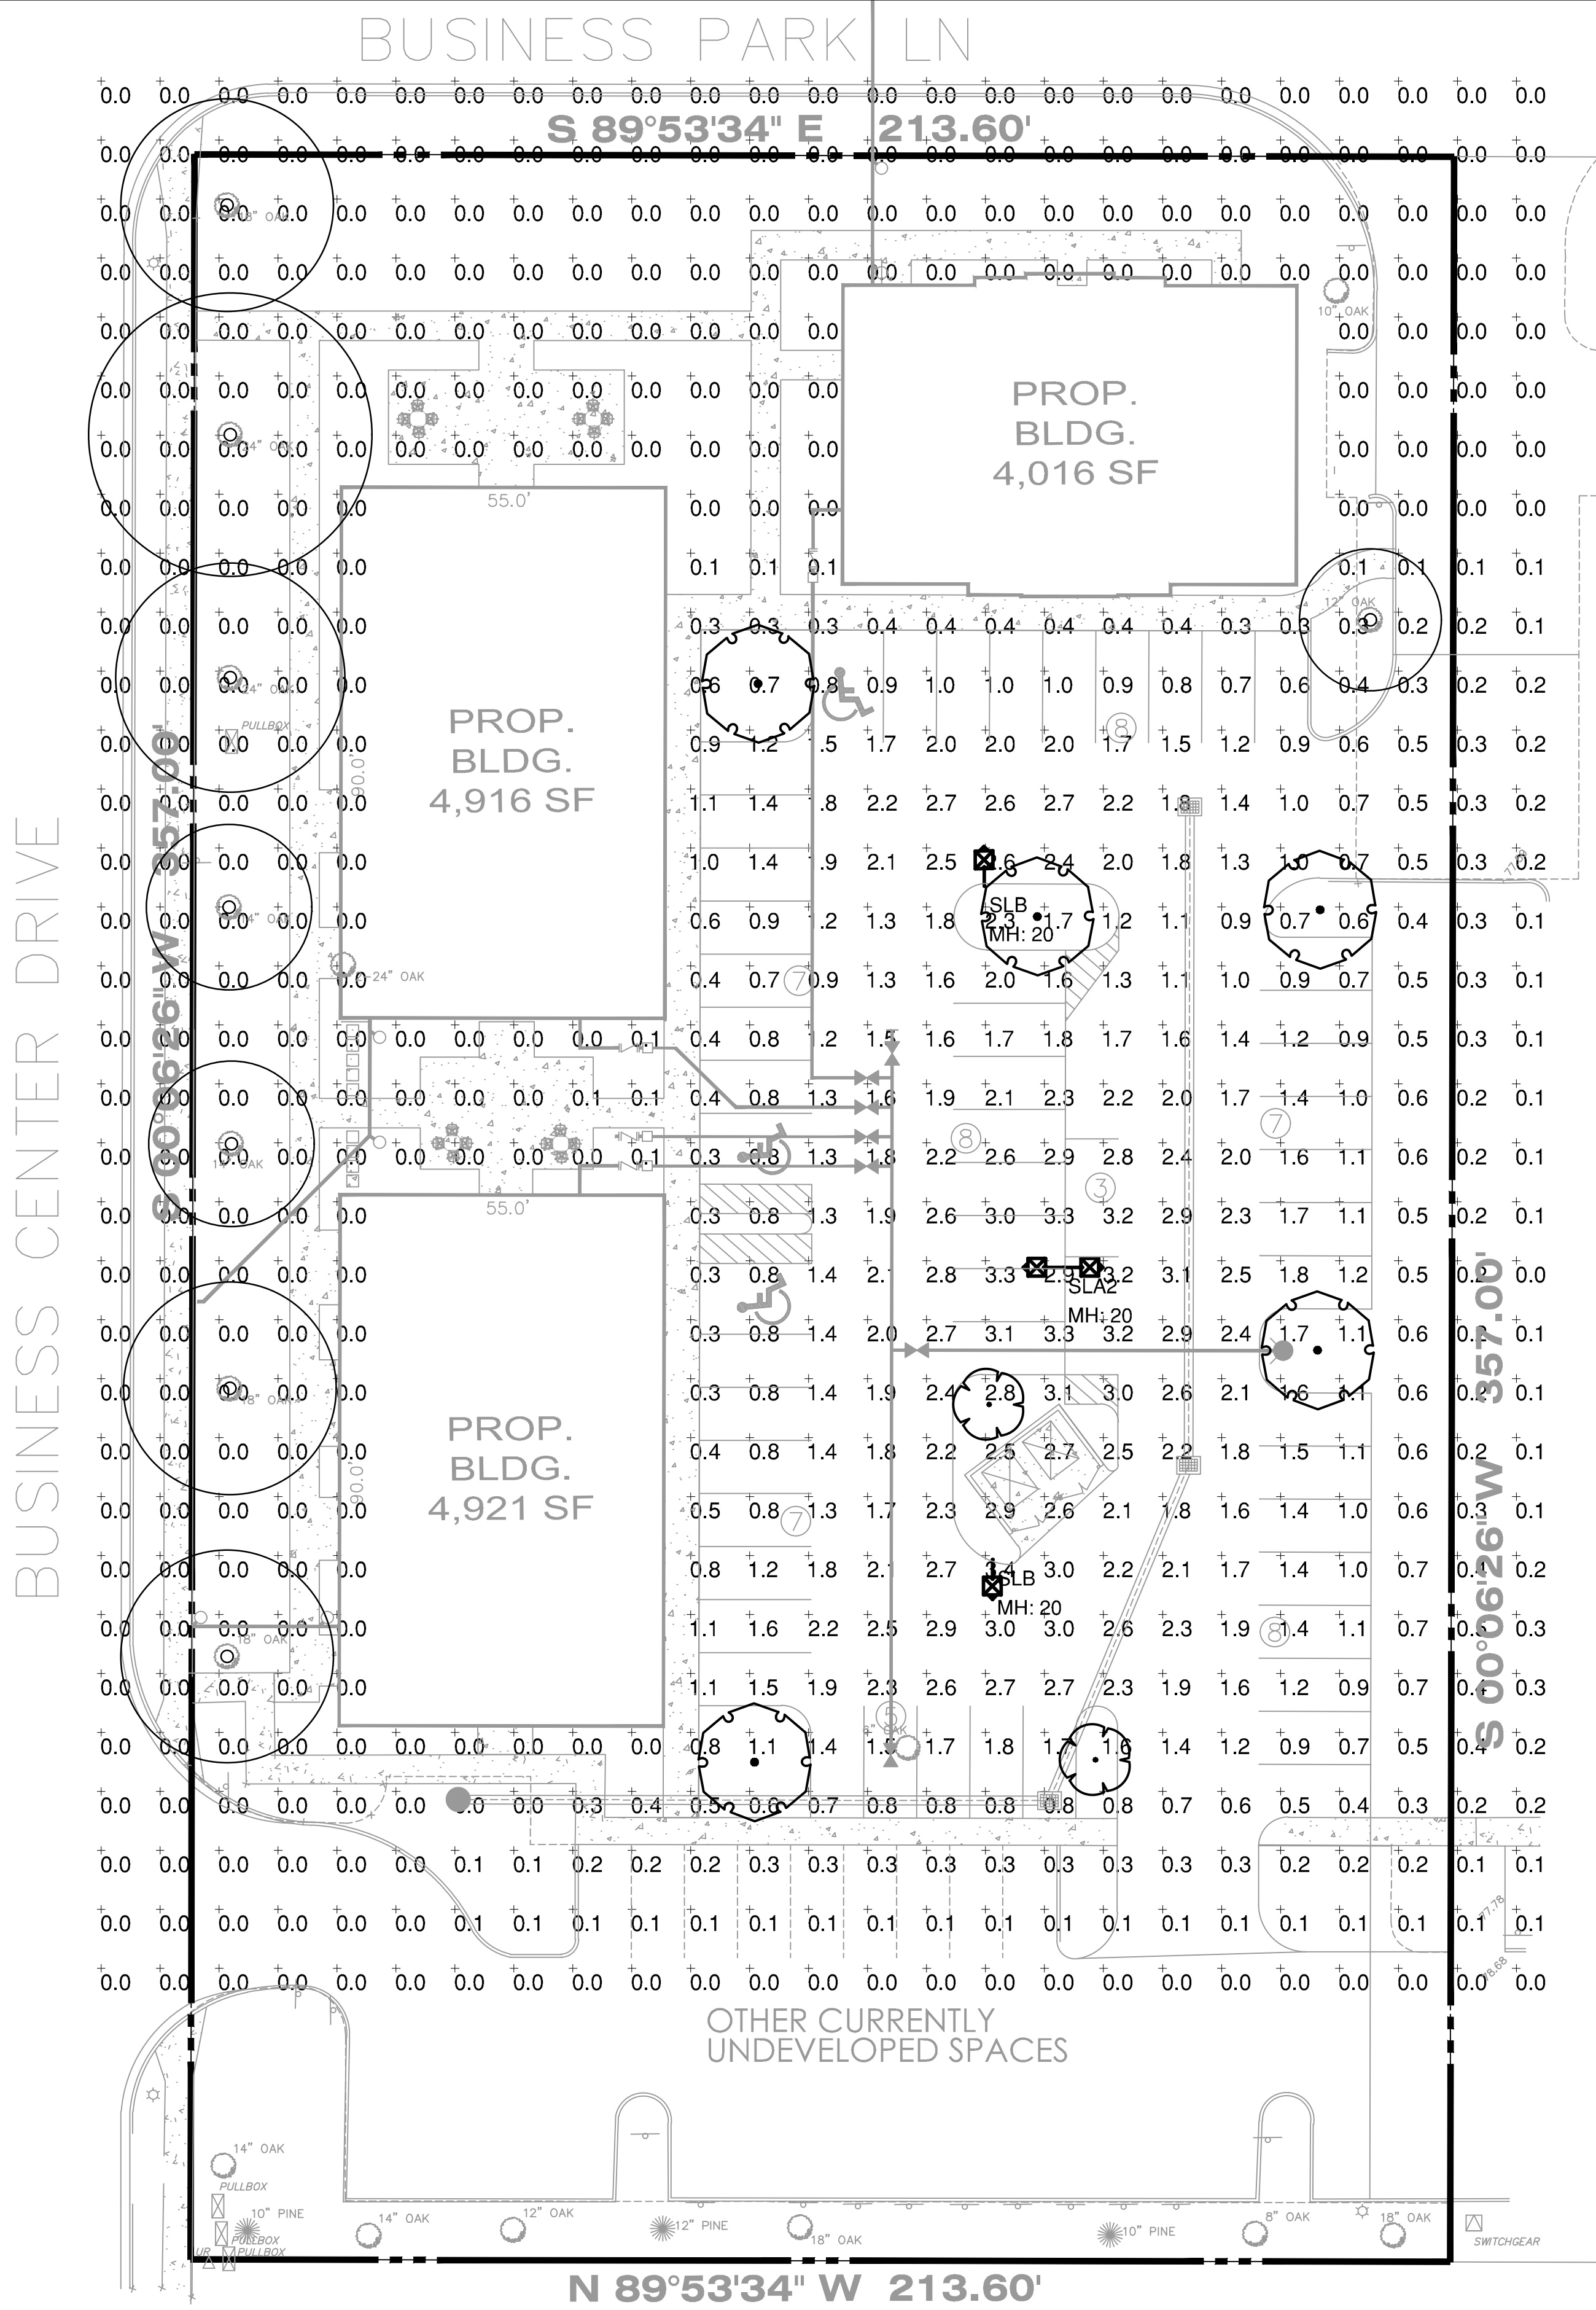


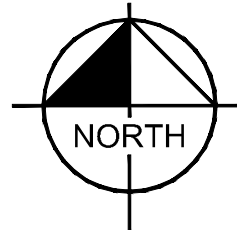


GRAPHIC SCALE IN FEET
0 10 20 40

Always call 811 two full business days before you dig to have underground utilities located and marked.



Landreth Lighting Luminaire Schedule									
Symbol	Manufacturer	Qty	Label	Arrangement	Description	LLF	BUG Rating	Arranged Watts	Arranged Lumens
	Lithonia Lighting	1	SLA2	Back-Back	DSX0 LED P4 40K 70CRI T5M MVOLT RPA NLTAIR2 PIRHN FINISH TBD: MOUNTED 20' AFG ON ROUND TAPERED ALUMINUM POLE	1.000	B4-U0-G2	186.08	23240
	Lithonia Lighting	2	SLB	Single	DSX0 LED P4 40K 70CRI T2M MVOLT RPA NLTAIR2 PIRHN FINISH TBD: MOUNTED 20' AFG ON ROUND TAPERED ALUMINUM POLE	1.000	B2-U0-G3	93.04	11002

Landreth Lighting Calculation Summary								
Label	CalcType	Units	Avg	Max	Min	Avg/Min	Max/Min	
Parking Lot	Illuminance	Fc	1.75	3.4	0.4	4.38	8.50	

LAKE MARY OFFICE BUILDINGS

SHEET NUMBER L4.00

PHOTOMETRICS PLAN

KHA PROJECT 249659000

DATE 12/10/2024

SCALE AS SHOWN

DESIGNED BY JTD

DRAWN BY JTD

CHECKED BY GSW

LICENSED PROFESSIONAL ARCHITECT

LA6667156

STATE OF FLORIDA

GREGORY S. WITHERSPOON

Kimley»Horn

© 2023 KIMLEY-HORN AND ASSOCIATES, INC.
200 S. ORANGE AVENUE, SUITE 600, ORLANDO, FL 32801
PHONE: 407-898-1511
WWW.KIMLEY-HORN.COM

REVISIONS

No.	DATE	BY

FLORIDA

LAKE MARY

12/19/2024

