


CAMPBELL + VAN DUSEN  
ARCHITECTURE INTERIOR DESIGN  
www.CVdStudio.com  
CAMPBELL + VAN DUSEN Design Studio, LLC.  
255 South Orange Avenue Suite #1240  
Orlando, Florida 32801  
Phone: 407.930.6016  
FL Lic. No. AA26003339

ARCHITECT OF RECORD  
FRANK W. CAMPBELL AIA  
FL LIC. NO. AR0016053  
COPY OF THIS PLAN IS NOT VALID UNLESS SIGNED,  
SEALED AND DATED BY THE ARCHITECT OF RECORD.

TAGS  
ENGINEERING  
MEP, Fire Protection, Energy Modeling,  
Sustainability Consulting  
Certification of Authorization Number: 2016  
Address: 1821 Lake Dr, Sanford, FL 32799  
Tel: (407) 443-9568  
www.tagseng.com

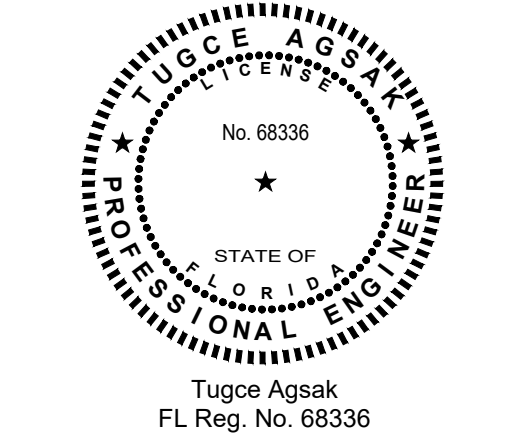

Tugoe Agsak  
FL Reg. No. 68336  
COPY OF THIS PLAN IS NOT VALID UNLESS SIGNED,  
SEALED AND DATED BY THE ENGINEER OF RECORD.

PROJECT DESCRIPTION:  
HEATHROW CENTRE  
BUILDING - 02  
EMPTY SHELL BUILDING  
1165 BUSINESS CENTER DRIVE  
SUITE 1025 AND SUITE 1075  
LAKE MARY, FLORIDA. 32746

CONSTRUCTION

10.24.2025

NO.	DESCRIPTION	DATE


PROJECT TEAM  
PRINCIPAL IN CHARGE  
T. AGSAK  
PROJECT MANAGER  
L. YOUNG

CLIENT NAME  
Providence One Partners


PROJECT NUMBER  
24-0919-01

MECHANICAL ROOF  
PLAN AND DETAILS

SHEET NUMBER  
M2.0

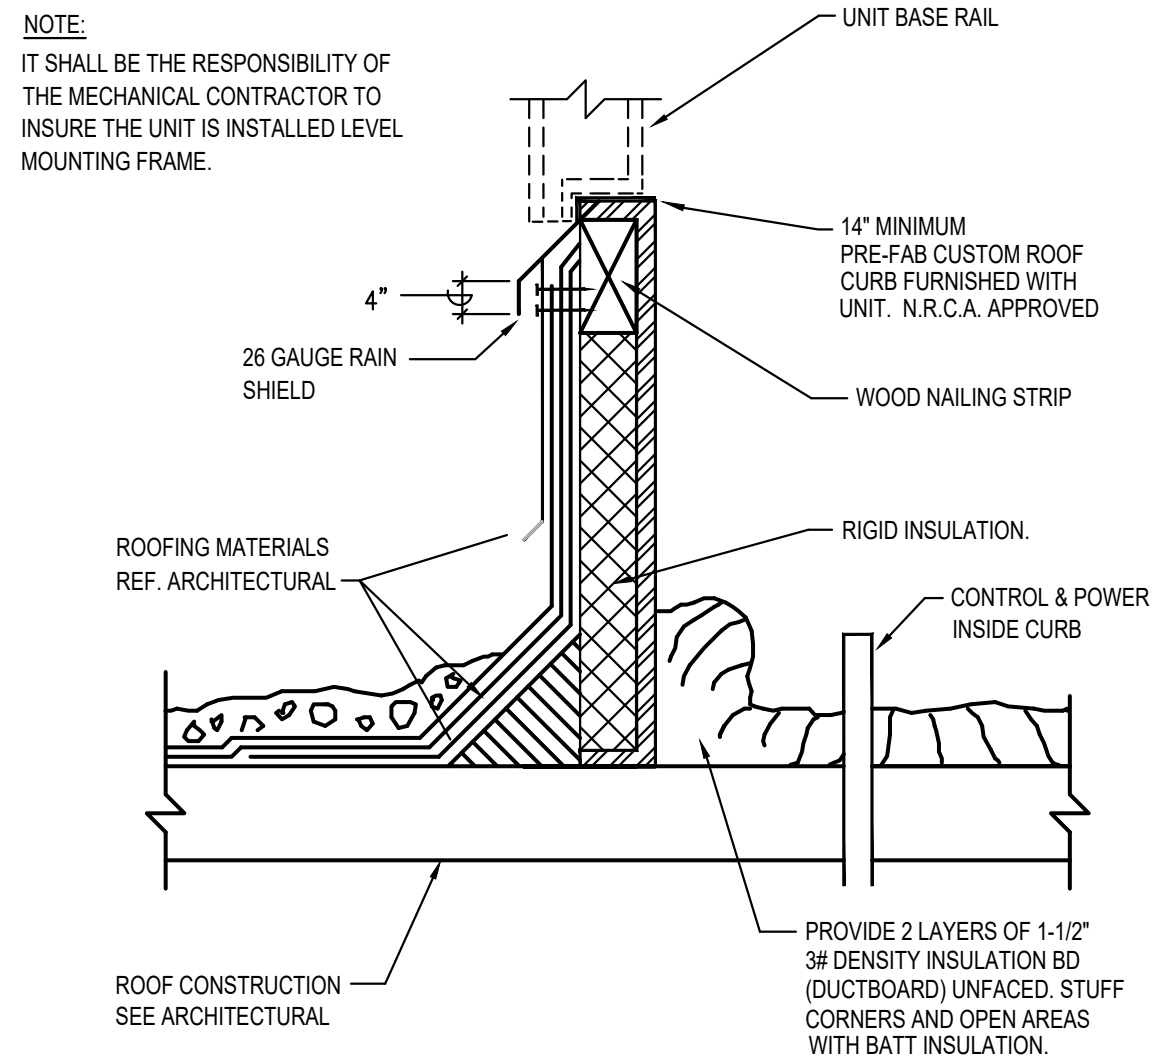

3 ROOF CURB DETAIL  
NOT TO SCALE

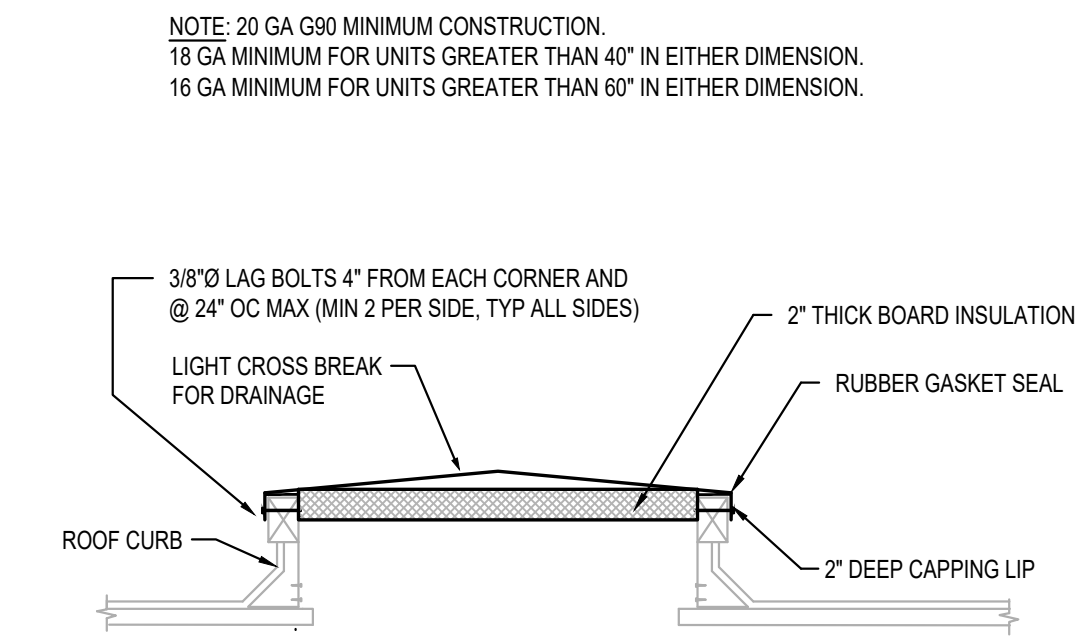


2 ROOF CURB CAP DETAIL  
NOT TO SCALE


SYMBOL	DESCRIPTION
	MECHANICAL EQUIPMENT
	CEILING SUPPLY AIR DIFFUSER
	CEILING RETURN AIR GRILLE
	CEILING EXHAUST AIR GRILLE
	NEW DUCTWORK
	EXISTING DUCTWORK TO REMAIN
	EXISTING DUCTWORK TO BE REMOVED
UNO	UNLESS NOTED OTHERWISE
UC	POINT OF CONNECTION
UNDERCUT	UNDERCUT
SA	SUPPLY AIR
OA	OUTSIDE AIR
EA	EXHAUST AIR
RA	RETURN AIR
M11MS.01	MECHANICAL RISER NUMBER AND SHEET REFERENCE

NOTE: NOT ALL SYMBOLS ABOVE ARE NOT NECESSARILY USED ON THE DRAWINGS.

1 MECHANICAL SYMBOLS  
NOT TO SCALE

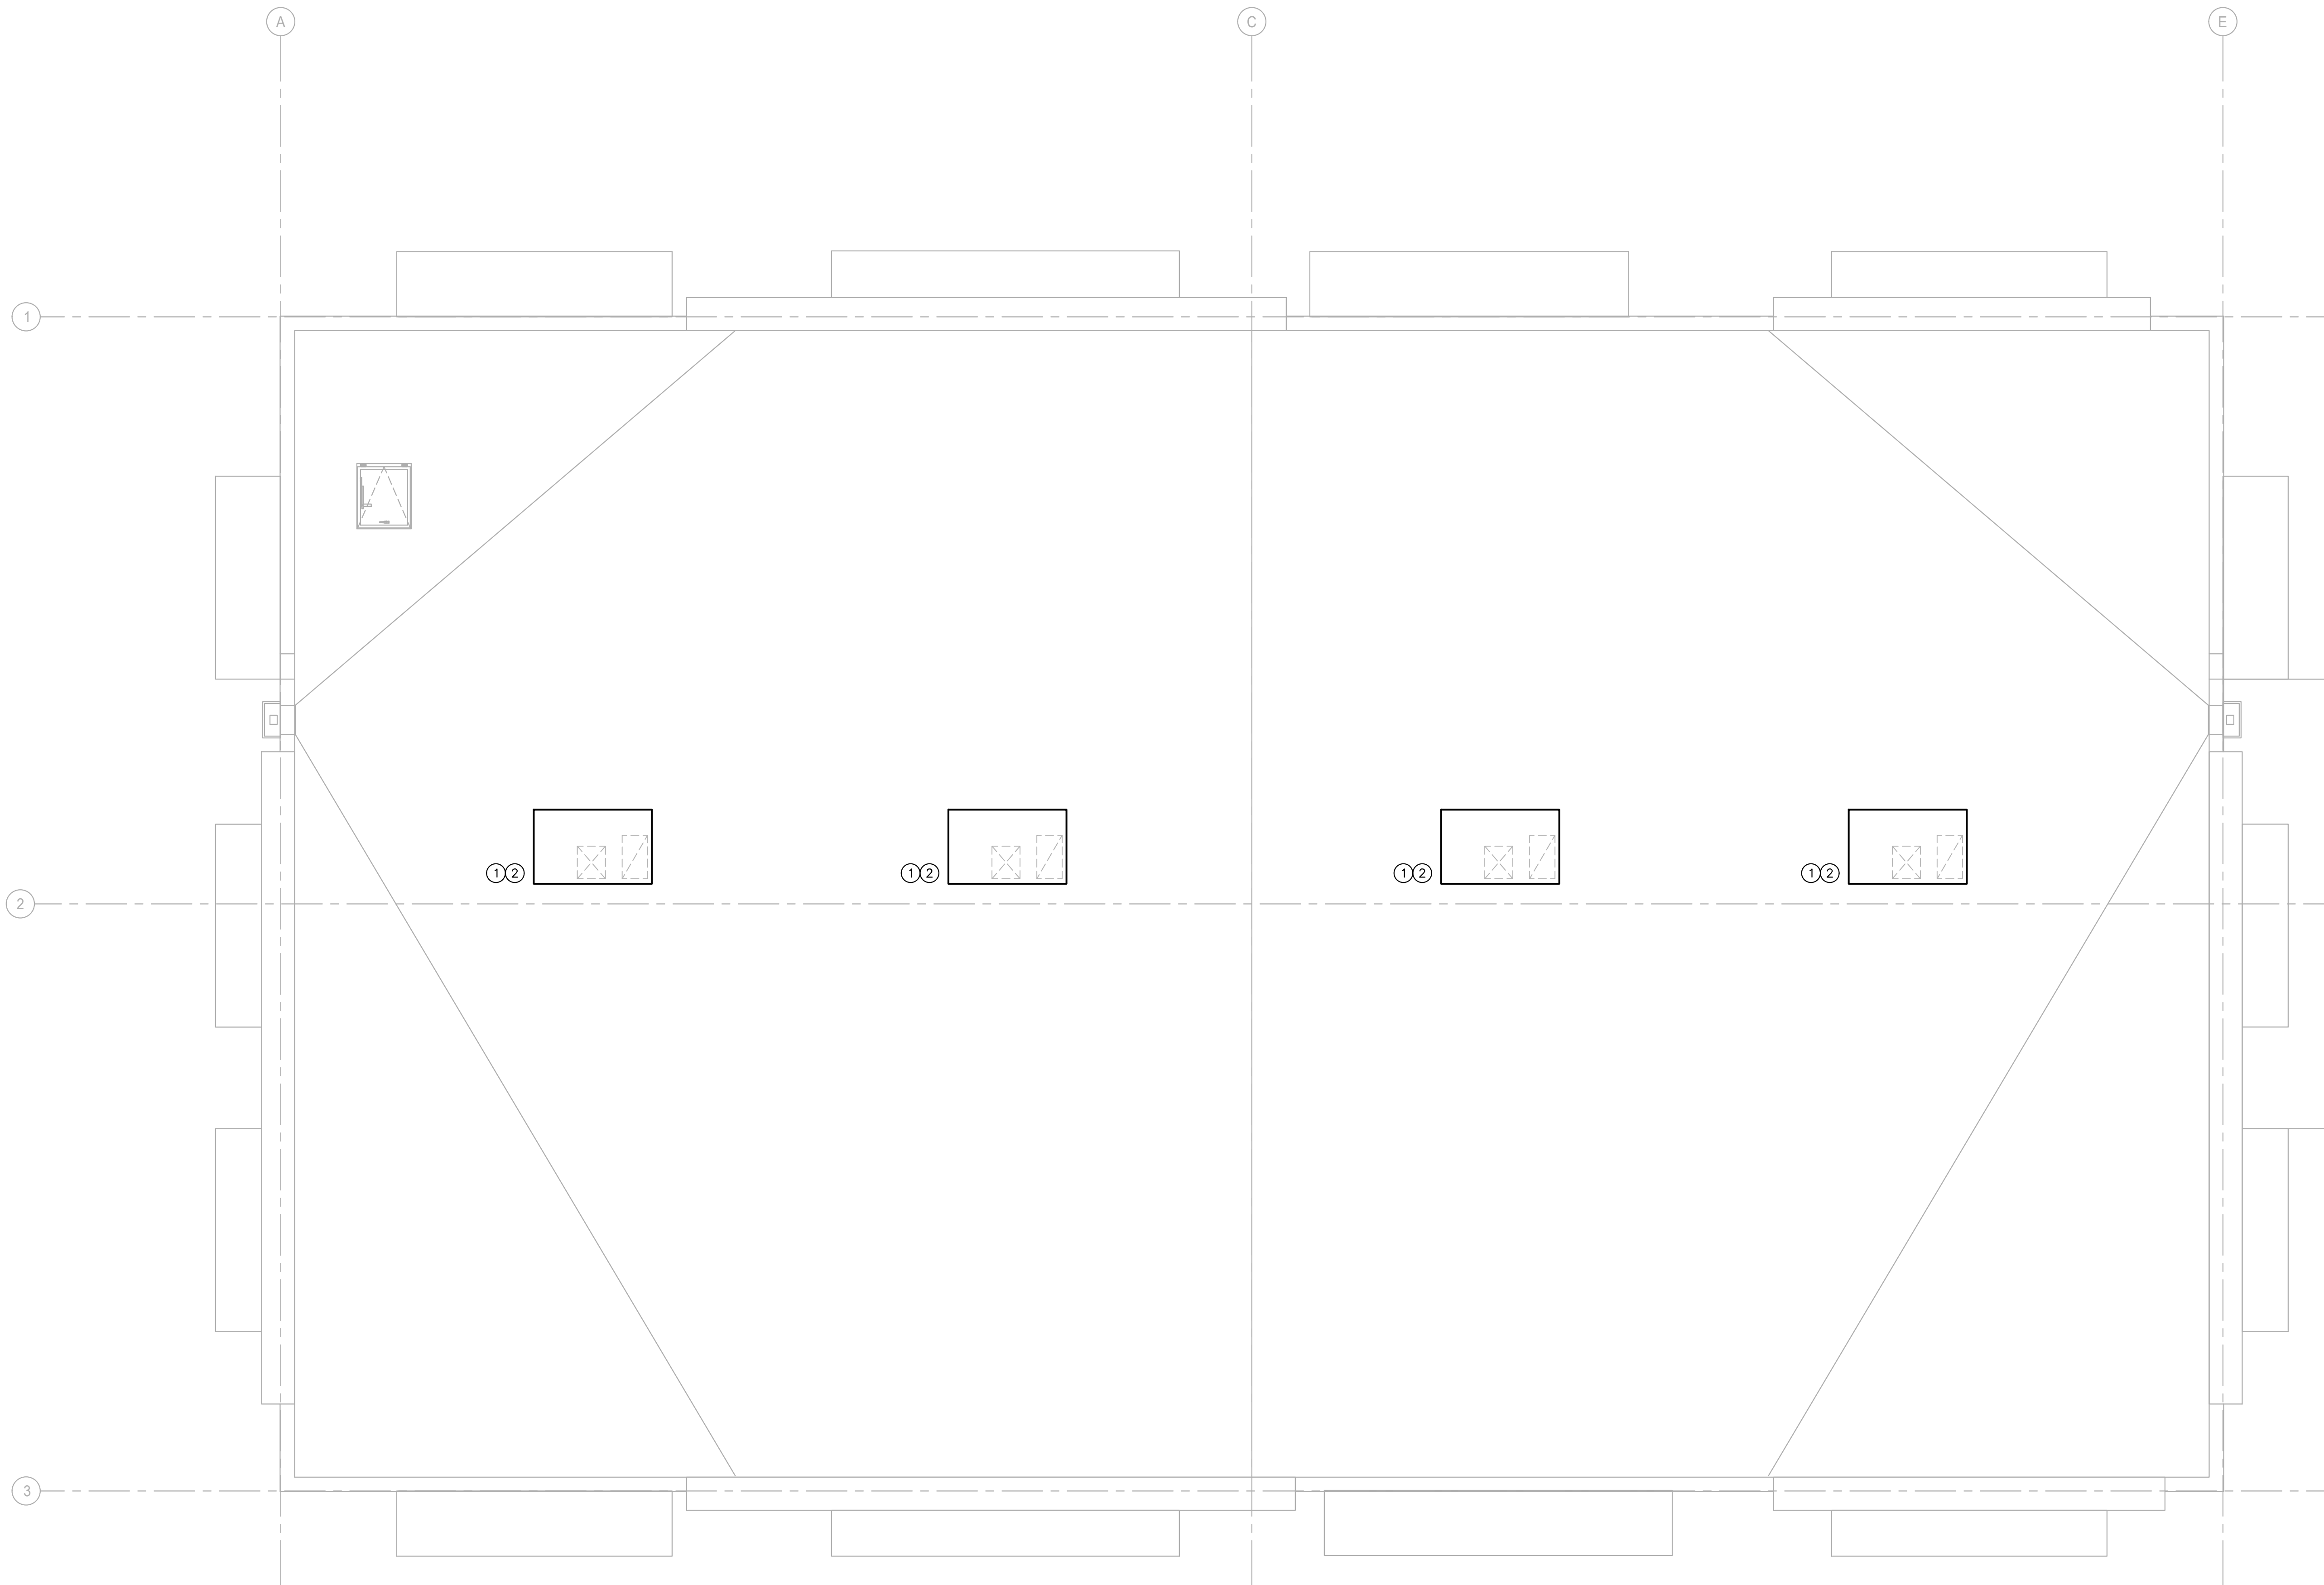

NORTH

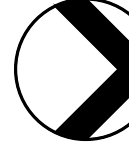

1/M2.0 MECHANICAL ROOF PLAN

SCALE: 1/4" = 1'-0"